


**FIXTURE TYPE 'A' TO 'C'**  
SCALE: N.T.S.

Symbol	Label	Qty	Catalog Number	Description	Lamp	File	Lumens	LLF	Watts
⊗	A	8	LITHONIA CAT.# DSXW1 LED 10C 1000 30K T3M MVOLT	DSXW1 LED WITH (1) 10 LED LIGHT ENGINES, TYPE T3M OPTIC, 3000K, @ 1000mA. MOUNTED AT APPROX. 9 FT A.F.F. IDA APPROVED - 3,607 LUMENS BUG RATING: B1 U0 G1	LED	DSXW1_LED_10C_1000_30K_T3M_MVOLT.ies	Absolute	0.95	38.8
⊗	B	2	LITHONIA CAT.# DSXW1 LED 10C 1000 30K TFTM MVOLT	DSXW1 LED WITH (1) 10 LED LIGHT ENGINES, TYPE TFTM OPTIC, 3000K, @ 1000mA. MOUNTED AT APPROX. 9 FT A.F.F. IDA APPROVED - 3,673 LUMENS BUG RATING: B1 U0 G1	LED	DSXW1_LED_10C_1000_30K_TFTM_MVOLT.ies	Absolute	0.95	38.8
⊗	C	7	LITHONIA CAT.# DSXW1 LED 10C 530 30K T2M MVOLT	DSXW1 LED WITH (1) 10 LED LIGHT ENGINES, TYPE T2M OPTIC, 3000K, @ 530mA. MOUNTED AT APPROX. 9 FT A.F.F. IDA APPROVED - 1,957 LUMENS BUG RATING: B1 U0 G1	LED	DSXW1_LED_10C_530_30K_T2M_MVOLT.ies	Absolute	0.95	19.1

STATISTICS						
Description	Symbol	Avg	Max	Min	Max/Min	Avg/Min
Calc Zone #1	+	1.6 fc	5.8 fc	0.1 fc	58.0:1	16.0:1
LIGHTING ZONE 3 - LOW AMBIENT BRIGHTNESS - 0.3 FC ALLOWABLE AT PROPERTY LINE.						

These drawings, specifications, etc. are the property of R. M. Montgomery Engineering Inc. and must be returned upon request. Any duplication, reuse, revisions and/or distribution in part or whole without the prior written authorization of R. M. Montgomery Engineering Inc. is strictly prohibited. Each contractor shall check and verify all dimensions and report all errors and omissions to the Engineer.  
These documents reflect the best judgment of R. M. Montgomery Engineering Inc. in light of the information available to them at the time of preparation. Any use which a third party makes of these documents, or any reliance on or decisions to be made based on them, is the sole responsibility of such third party. R. M. Montgomery Engineering Inc. accepts no responsibility for damages, if any, suffered by any third party as a result of decisions made or actions based on these documents.  
Do not scale these drawings.  
Copyright 2022 R. M. Montgomery Engineering Inc.

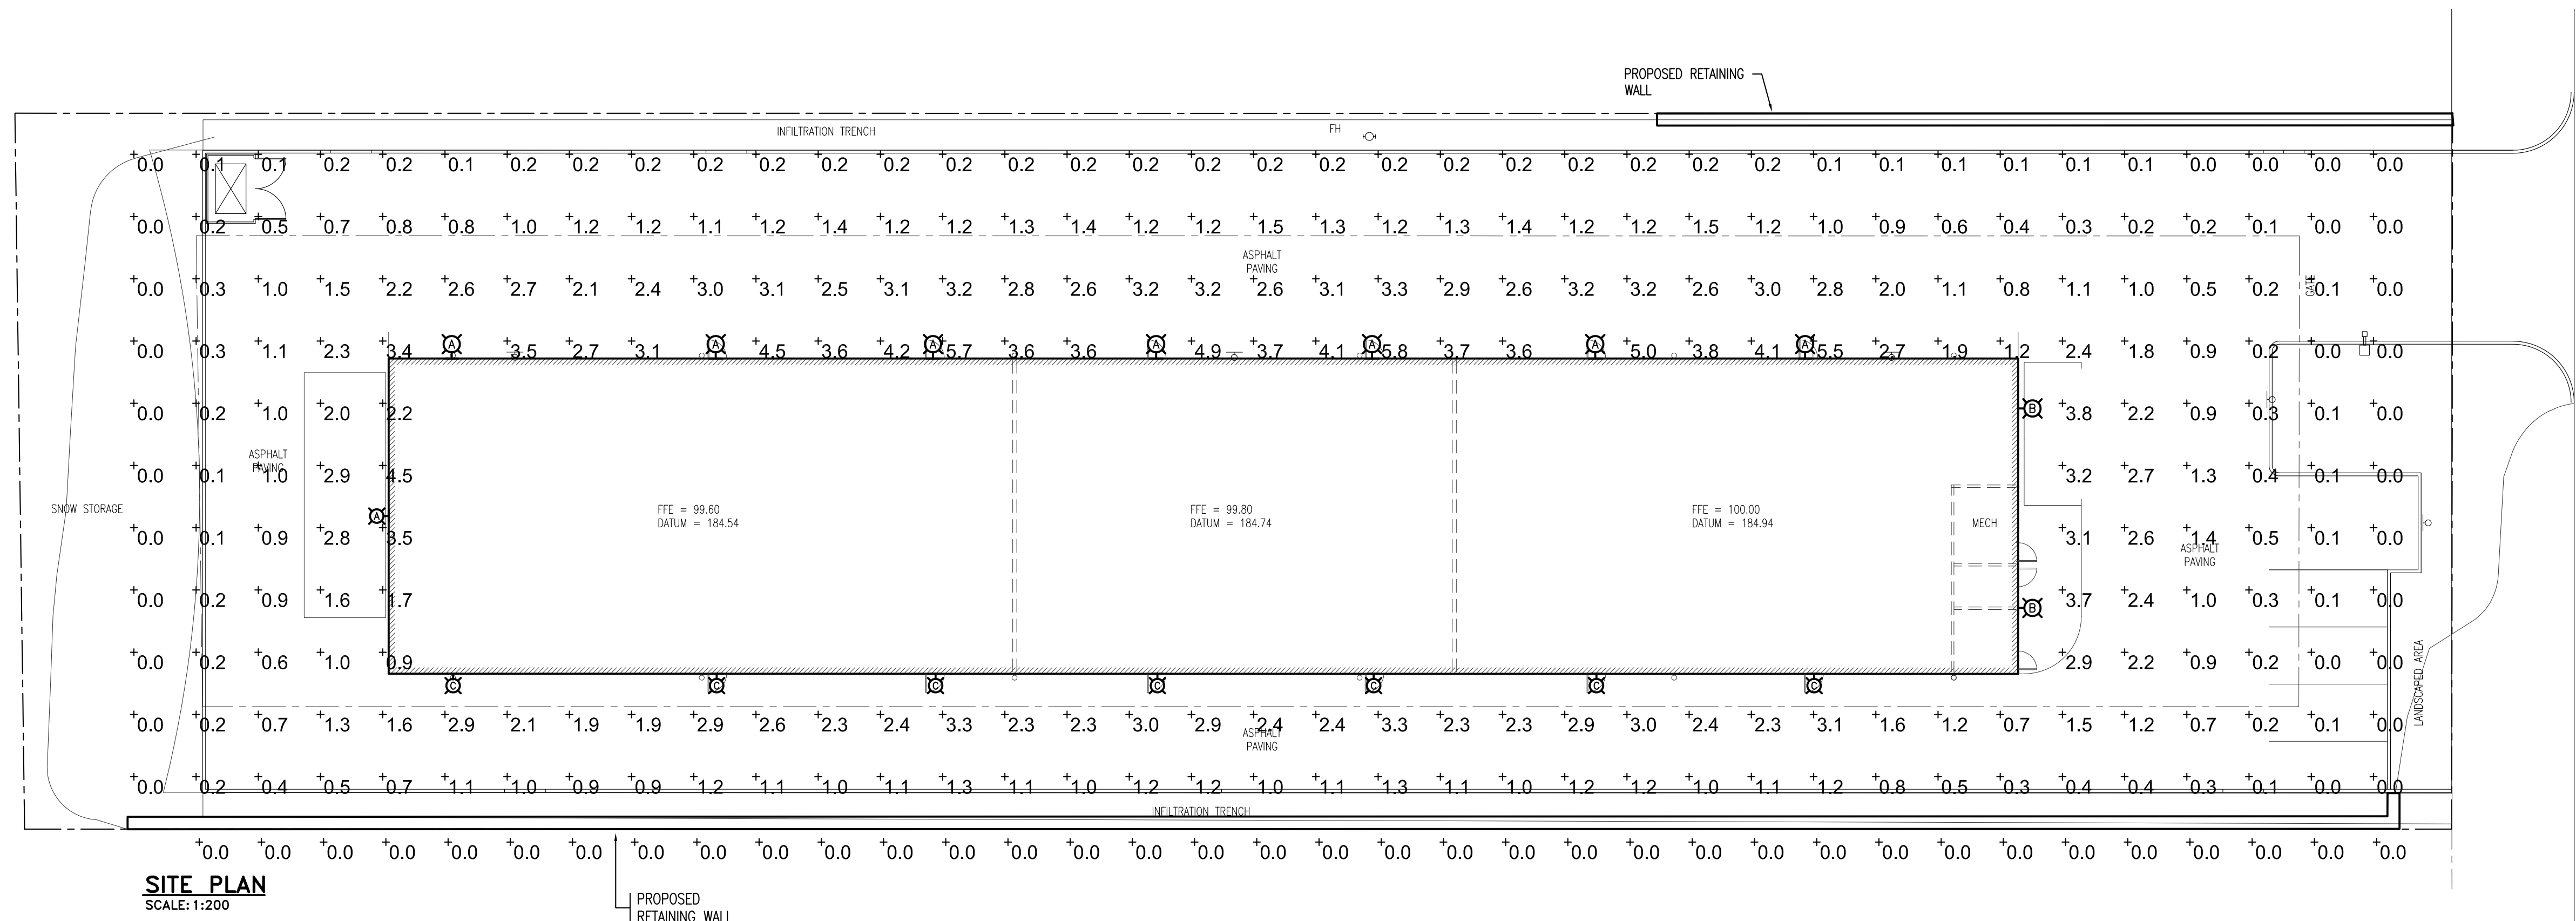

**SITE PLAN**  
SCALE: 1:200

WHITFIELD CRESCENT

NO	DATE	DESCRIPTION	BY
1	JAN. 07 '22	ISSUED FOR SITE PLAN APPROVAL	R.M.

REVISIONS

**R.M. MONTGOMERY ENGINEERING INC.**  
MECHANICAL & ELECTRICAL ENGINEERS  
5C-291 WOODLAWN RD W., GUELPH, ON N1H 7L6  
TEL: (519) 767-0514 FAX: (519) 767-1361

OWNER  
**APPLE SELF STORAGE**  
16 INDUSTRIAL PARKWAY SOUTH  
AURORA, ONTARIO

PROJECT TITLE  
**PROPOSED SELF STORAGE**  
249 WHITFIELD CRES.  
MIDLAND, ONTARIO

DRAWING TITLE  
**SITE PLAN PHOTOMETRIC AND STATISTICS**

DRAWN BY <b>R.V.</b>	CHECKED BY <b>R.M.</b>	SCALE <b>AS NOTED</b>
PROJECT No. <b>AP-48</b>	DATE <b>JAN. '22</b>	DRAWING No. <b>ESL01</b>